



BAKERSFIELD
DIVISION

BOX 81376
315 30TH STREET (93301)
BAKERSFIELD, CA 93380-1376

PHONE: (661) 633-5368
FAX: (661) 410-0460

This plan is prepared by A-C Electric Company for its sole use as a design build electrical contractor in the presentation, budgeting and installation phases of the subject project. This plan is only a schematic representation of the electrical work and its use by others is prohibited and no liability is assumed for any unauthorized use.


CTERTC - IHS
SITE UNDERGROUND ROUTING

22501 UNION AVE., SUITE A
BAKERSFIELD, CA
93305

JOB NAME	LOCATION ON SITE	JOB DESCRIPTION
----------	------------------	-----------------

[illegible]

CAD FILENAME	BR0563-0200 Site UG RT.dwg
DATE	07/9/2018
PROJECT NO.	BR0563
SCALE	1/32"=1'-0"
DWG. NO.	0563-0200

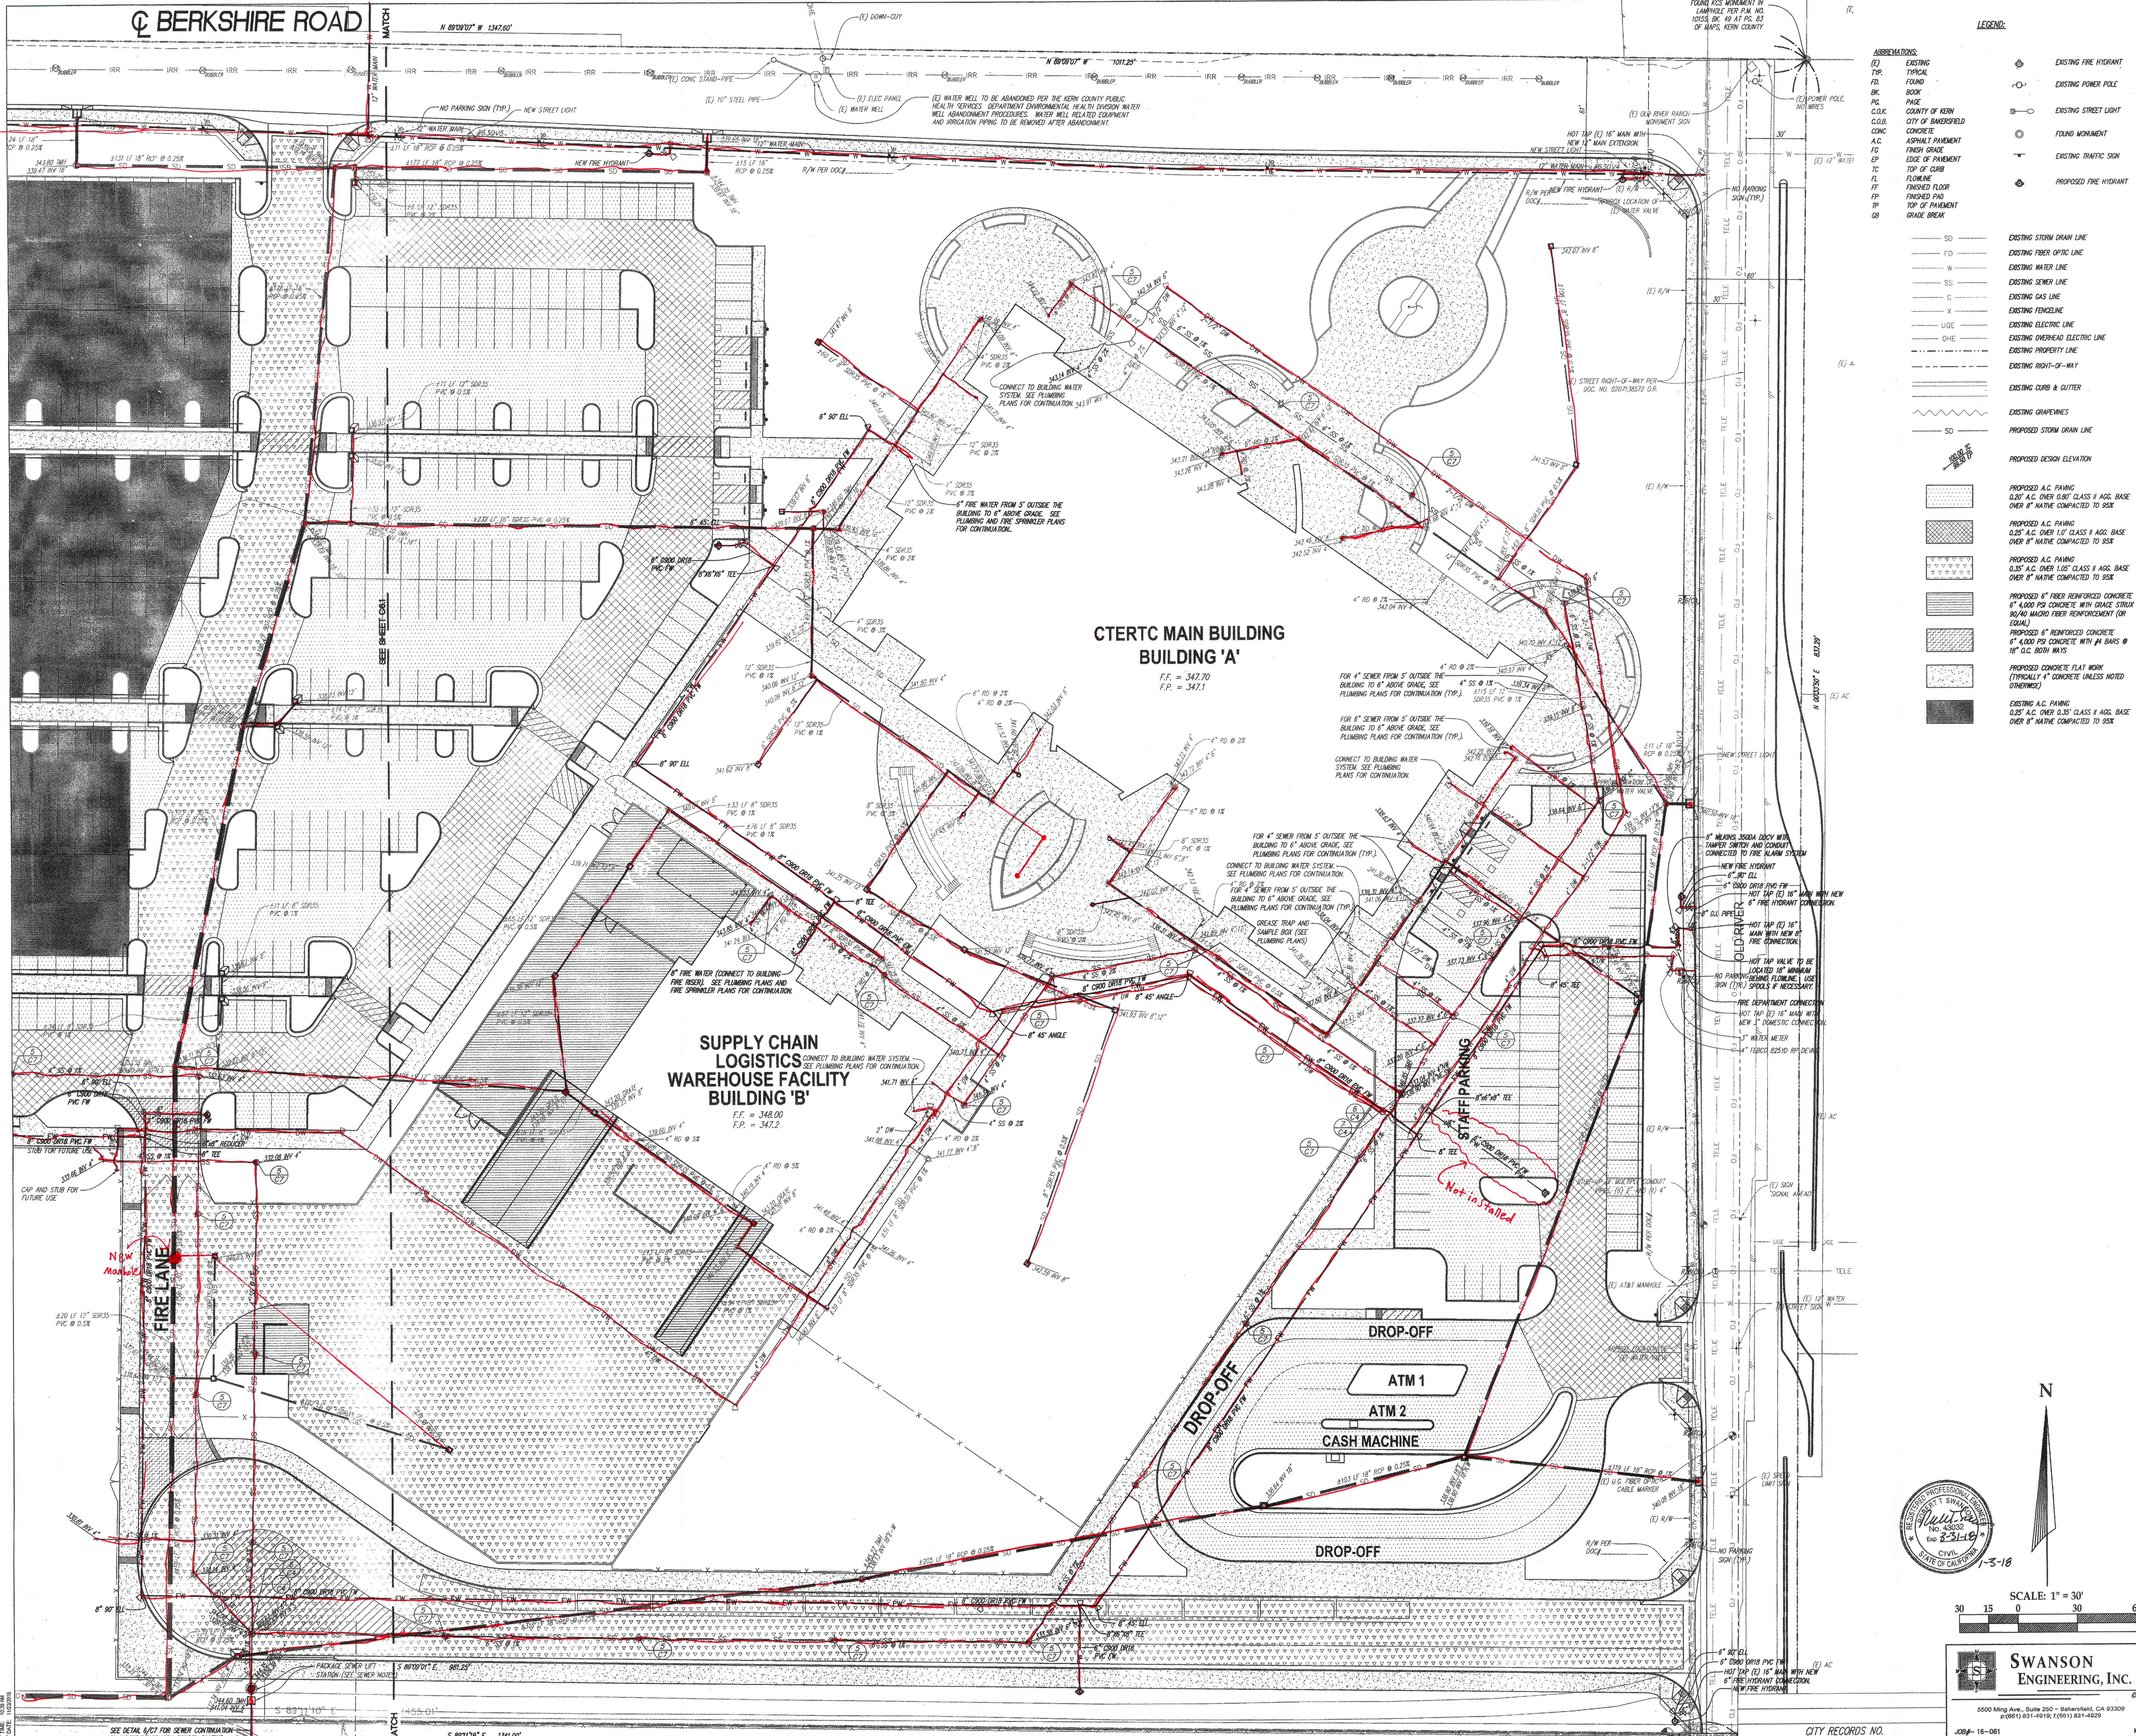

ORDIZ MELBY
ARCHITECTS, INC.

5500 MING AVENUE SUITE 280
BAKERSFIELD, CALIFORNIA 93309
TELEPHONE (805) 832-5258
FACSIMILE (805) 832-4291

ARCHITECT
No. 0-10835
JANUARY 31, 2018
DATE

DANNY E. ORDIZ, AIA
ARCHITECT
WILLIAM J. MELBY, AIA
ARCHITECT

IDENTIFICATION STAMP
DIVISION OF STATE ARCHITECT
OFFICE OF REGULATION SERVICES

APP# 03-117718
FILE # 15-413

AC JAN 18 2018
DATE

PTNR : 63529-0260

INDEPENDENCE H.S.'S
NEW CTERTC BUILDING
& LOGISTICS TRAINING
CENTER
7301 OLD RIVER ROAD
BAKERSFIELD, CA

FOR:
**KERN HIGH
SCHOOL DISTRICT**



MARK	DATE	DESCRIPTION

JOB NUMBER:
1762
CAD DRAWING FILE:
1762-KHSD-CTERTC-MAIN-BLDG-00-AC19

DRAWN BY:
MCN
CHECKED BY:
RIS


CHECK AND VERIFY ALL DIMENSIONS BEFORE
PROCEEDING WITH THE WORK.
REPORT DISCREPANCIES TO THE ARCHITECT.

THE DRAWINGS, IDEAS AND DESIGNS
REPRESENTED ON THIS SHEET ARE THE
PROPERTY OF THE ARCHITECT.

COPYRIGHT
ORDIZ-MELBY ARCHITECTS, INC. 2018

SHEET TITLE
SITE UTILITY PLAN-EAST

SHEET IDENTIFICATION NUMBER
C6

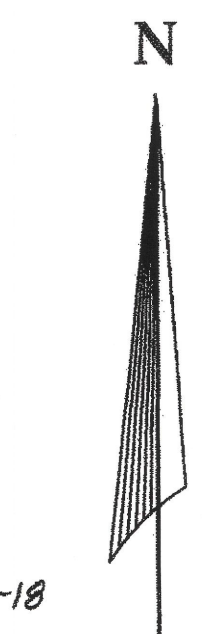

SWANSON
ENGINEERING, INC.

5500 Ming Ave., Suite 280 - Bakersfield, CA 93309
(805) 831-4918; (805) 831-4829